



10xDJF-1380
 @44000m /h×10=
 440,000m

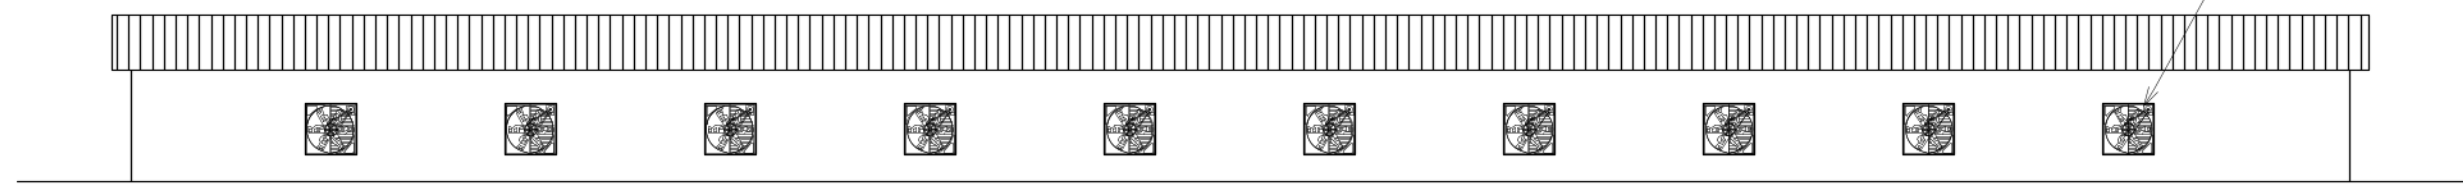


60000



 
3



移動通路

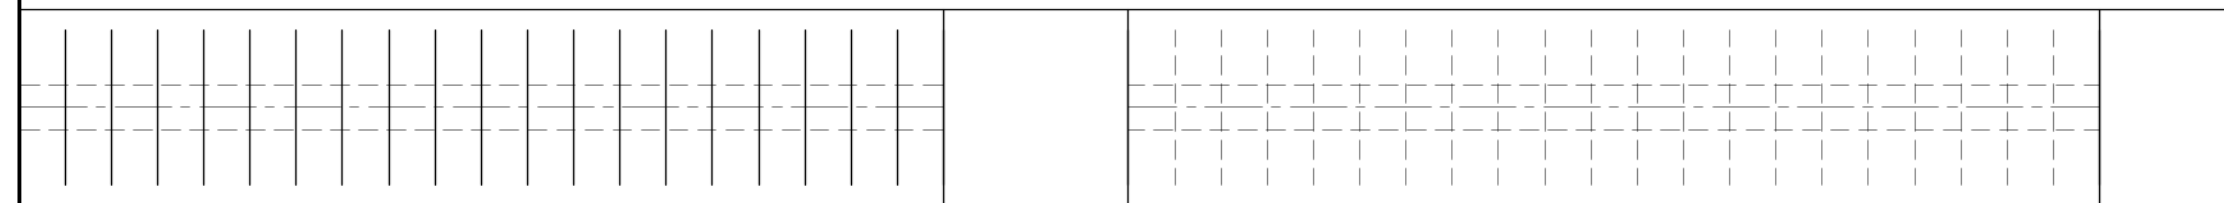


19200

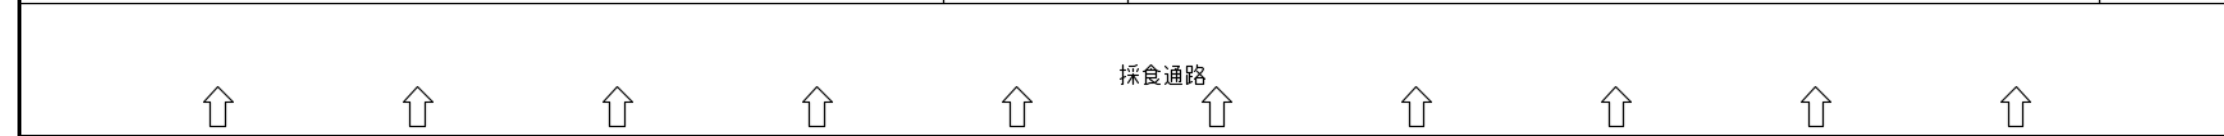

採食通路




 給餌通路




23×クーリングパット
 @1500X2300
 (1690x2344)

 800



@2344x23=53912

 特記事項



承認	検図	設計	製図	縮尺	A3 - 1/200
	田中	三浦		年月日	

工事名	
図名	トンネル換気計画図

図番	
番号	